
 






 
 
 
 
 



 
 
 
 
 
 


 
 


 
 



| INTERIOR LIGHTING ITEM  |  |  |    |   |  |                          |
|---|--|--|----|---|--|--------------------------|
|     |    | T-BAR CEILING RECESSED MOUNTED LED LIGHTING<br>FIXTURE, 2' X 4', 120V BAKED-ON WHITE ENAMEL FINISH.                                    | 3  | LSI<br>FIXTURE: SFP24-LED-50-UE-DIM-35  | KITCHEN CEILING LIGHTS,<br>FURNISHED BY OWNER INSTALLED BY GC  | 50                       |
|    |   | T-BAR CEILING RECESSED MOUNTED LED LIGHTING<br>FIXTURE, 2' X 2', 120V BAKED-ON WHITE ENAMEL FINISH.                                    | 4  | LSI<br>FIXTURE: SFP22-LED-30-UE-DIM-35-U  | KITCHEN CEILING LIGHTS,<br>FURNISHED BY OWNER INSTALLED BY GC  | 30                       |
|    |   | T-BAR CEILING RECESSED MOUNTED LED LIGHTING<br>EMERGENCY FIXTURE, 2' X 4', 120V BAKED-ON WHITE<br>ENAMEL FINISH.                       | 2  | LSI<br>FIXTURE: SFP24-LED-50-UE-DIM-EM  | EMERGENCY KITCHEN CEILING LIGHTS<br>FURNISHED BY OWNER INSTALLED BY GC   | 50                       |
|    |   | T-BAR CEILING RECESSED MOUNTED LED LIGHTING<br>EMERGENCY FIXTURE, 2' X 2', 120V, ALUMINUMUM<br>FRAME AND BAKED-ON WHITE ENAMEL FINISH. | 1  | LSI<br>FIXTURE: SFP22-LED-30-UE-DIM-35-U-EM   | EMERGENCY KITCHEN CEILING LIGHTS,<br>FURNISHED BY OWNER INSTALLED BY GC  | 30                       |
|    |   | UNIVERSAL MOUNT EXIT SIGN, LED LIGHTED, 120/277V<br>WITH BATTERY PACK, 2 FACE, GREEN LETTER  | 3  | EXITRONIX GVEX-U-BP-WB-BL-R6  | EXIT SIGN<br>FURNISHED BY OWNER, INSTALLED BY GC   | 3.6                      |
|    |   | HOOD LIGHT   | 10 | FURNISHED & INSTALLED BY EQUIPMENT<br>SUPPLIER  | LIGHTS SUPPLIED & PRE-WIRED BY HOOD VENDOR.<br>ELECTRIC CONTRACTOR TO CONNECT MAIN WIRES TO SHUNT TRIP<br>BREAKER AND HOOD CONTROL PANEL | BUILT INTO HOOD          |
|    |   | WALK-IN COOLER FLUORESCENT LIGHT, 120 V 48"  | 3  | KASON<br>FIXTURE: # 18180F00048   | FURNISHED BY WIC VENDOR, G.R.E., INSTALLED BY GC   | 40                       |
|    |   | DOWN LIGHT, RECESSED IN CEILING  | 45 | ELITE HOUSING: LD6IC-AT<br>LED MODULE: ELITE LED LIGHTING<br>RL607-750L-DIMTR-120-30K-SN-SN-90+ | FURNISHED BY OWNER, INSTALLED BY GC  | 14                       |
|    |   | EMERGENCY DOWN LIGHT, RECESSED IN CEILING  | 8  | ELITE HOUSING: LD6IC-AT<br>LED MODULE: ELITE LED LIGHTING<br>RL607-750L-DIMTR-120-30K-SN-SN-90+ | EMERGENCY RECESSED DOWN LIGHT - NORMALLY ON<br>INVERTER UNIT - ISOLITE, IMI-12-LC-V1<br>FURNISHED BY OWNER INSTALLED BY GC               | 14                       |
|    |   | 3 3/4" ADJUSTABLE MR16 DOWN LIGHT,<br>RECESSED IN CEILING  | 15 | LIGHTOLIER: LYTECASTER - 378WHX<br>FRAME-IN KIT: 302MRSFX<br>SPECIFIC: LED: 7XMR16D830/35       | FURNISHED BY OWNER, INSTALLED BY GC  | 6                        |
|    |   | NOT USED   | 0  |   |  |                          |
|    |   | WHITE LED AT SERVICE COUNTER SOFFIT & DINING<br>ROOM PARTIAL HEIGHT WALL   | 41 | LUXEM BRIGHT<br>FIXTURE: BLAZE LED  | FURNISHED BY OWNER, INSTALLED BY GC  | 1.3 WATTS<br>PER<br>FOOT |
|    |   | 9.8" DIA. DECORATIVE ISLA PENDANT<br>LF INCANDESCENT   | 0  | LBL LIGHTING, MODEL # LFS12CRSC2D60<br>WITH 4W MAX LED BULB LB-MISCA7084                        | HUNG @ 6'-6" AFF OVER DINING TABLES IN BETWEEN BOOTH<br>FURNISHED BY OWNER, INSTALLED BY GC (VERIFY W/ PANDA)                            | 4                        |
|    |   | 12" DIAMETER LED PENDANT FIXTURE<br>WITH OIL RUBBED BRONZE FINISH  | 4  | GENERATION LIGHTING, BAYLOR SERIES.<br>MODEL #P14610RB WITH LED BULB                            | FURNISHED BY OWNER, INSTALLED BY GC  | 9                        |
|   |  | MICRO INVERTER   | 1  | ISOLITE #IMI 125  | FURNISHED BY OWNER, INSTALLED BY GC  |                          |
|  | SPEAKER  |  |    | FURNISHED BY MUSIC VENDOR, INSTALLED BY MUSIC VENDOR  |  |                          |

NIGHT LIGHTING REQUIREMENTS: "NL" DESIGNATION INDICATED NIGHT LIGHT ON UNSWITCED CIRCUIT.

- ONE NL BY SERVICE COUNTER, POS / CASHIER
- ONE NL BY POS / CASHIER AT DRIVE THRU STATION IF APPLICABLE
- ONE NL BY EACH EXIT DOORS IN DINNING ROOM & BACK OF HOUSE
- ONE NL BY MANAGER STATION

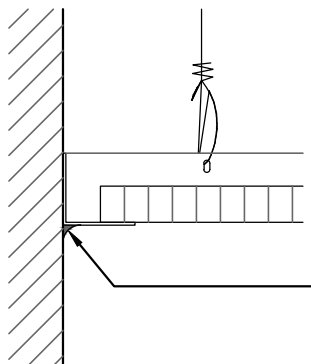
| EXTERIOR LIGHTING   |   |  |   |  |  |     |
|---|---|--|---|--|--|-----|
|  |  | LINEAR LIGHT AT EXTERIOR STORAGE ROOM  | 0 | COOPER<br>MX-4VT2-LD4-6-DR-UNV-L840-CD1-WL-U   | FURNISHED BY OWNER, INSTALLED BY GC  | 56  |
|  |  | WALL MOUNTED OVER SERVICE DOOR FIXTURE | 0 | HOWARD: V1.305<br>30W LED, BRONZE  | OVER EXTERIOR SERVICE DOOR. REFER ELEVATIONS FOR HEIGHT<br>FURNISHED BY OWNER, INSTALLED BY GC                             | 29  |
|  |  | NAVILITE EMERGENCY LIGHT               | 1 | EXITRONIX<br>MLED1-G-WP  | OVER EXTERIOR ENTRANCE & SERVICE DOORS. REFER ELEVATIONS<br>FOR HEIGHT. FURNISHED BY OWNER, INSTALLED BY GC                | 1.5 |
|  |  | EXTERIOR RECESS EMERGENCY LIGHT        | 1 | ELITE HOUSING: LD6IC-AT<br>LED MODULE: ELITE LED LIGHTING<br>WET LOCATION:<br>RL607-14W-120-FL-30K-SN-SN -WET LOCATION | EMERGENCY RECESSED DOWN LIGHT - NORMALLY ON<br>INVERTER UNIT - ISOLITE, IMI-12-LC-V1<br>FURNISHED BY OWNER INSTALLED BY GC | 14  |
|  |  | DECORATIVE LED WALL SCONCE             | 0 | HINKLEY LIGHTING,<br>ATLANTIS; BRONZE; 1649B2-LED  | AT PORTAL OF ENTRY DOOR. REFER ELEVATIONS FOR HEIGHT<br>FURNISHED BY OWNER, INSTALLED BY GC                                | 6   |
|  |  |  |   | LITHONIA LIGHTING  |  |     |

### CEILING SCHEDULE

INSTALLED AND FURNISHED BY G.C. UNLESS NOTED OTHERWISE

| NO | MANUFACTURER | DESCRIPTION                                 | MATERIAL                                  | FINISH   |
|----|--------------|---|---|--|
|    | ARMSTRONG    | 2' X 2' SUSPENDED T-BAR GRID CEILING SYSTEM | CUSTOM #PN91311                           | T-BAR AND GRID COLOR: SEPIA<br>CONTACT AT ARMSTRONG-SHERRY<br>BRUNT 1-800-442-4212 |
|    | USG          | 2' X 4' SUSPENDED T-BAR GRID CEILING SYSTEM | "VINYL ROCK" VINYL CLAD GYP. BD<br>PANELS | SMOOTH AND WASHABLE WHITE  |
|    | GOLD BOND    | MONOLITHIC CEILING ON METAL FRAMING         | 5/8" GYP. BD.                             | SMOOTH PAINT - WHITE AND WASHABLE  |

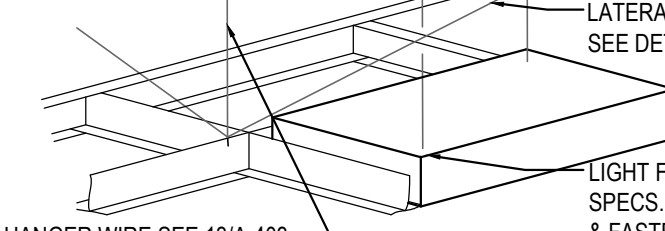
SEE SHEET A-103 FOR PAINT SCHEDULE



G.C. TO APPLY CONTINUOUS CLEAR SILICONE SEALANT AT PERIMETER GRID / FRP JOINT. TYPICAL THROUGHOUT B.O.H. CEILING

#### NOTE:

PROVIDE 4 VERTICAL WIRES (ATTACHED TO MAIN RUNNERS) WITHIN 3" OF EACH CORNER OF EACH FIXTURE.



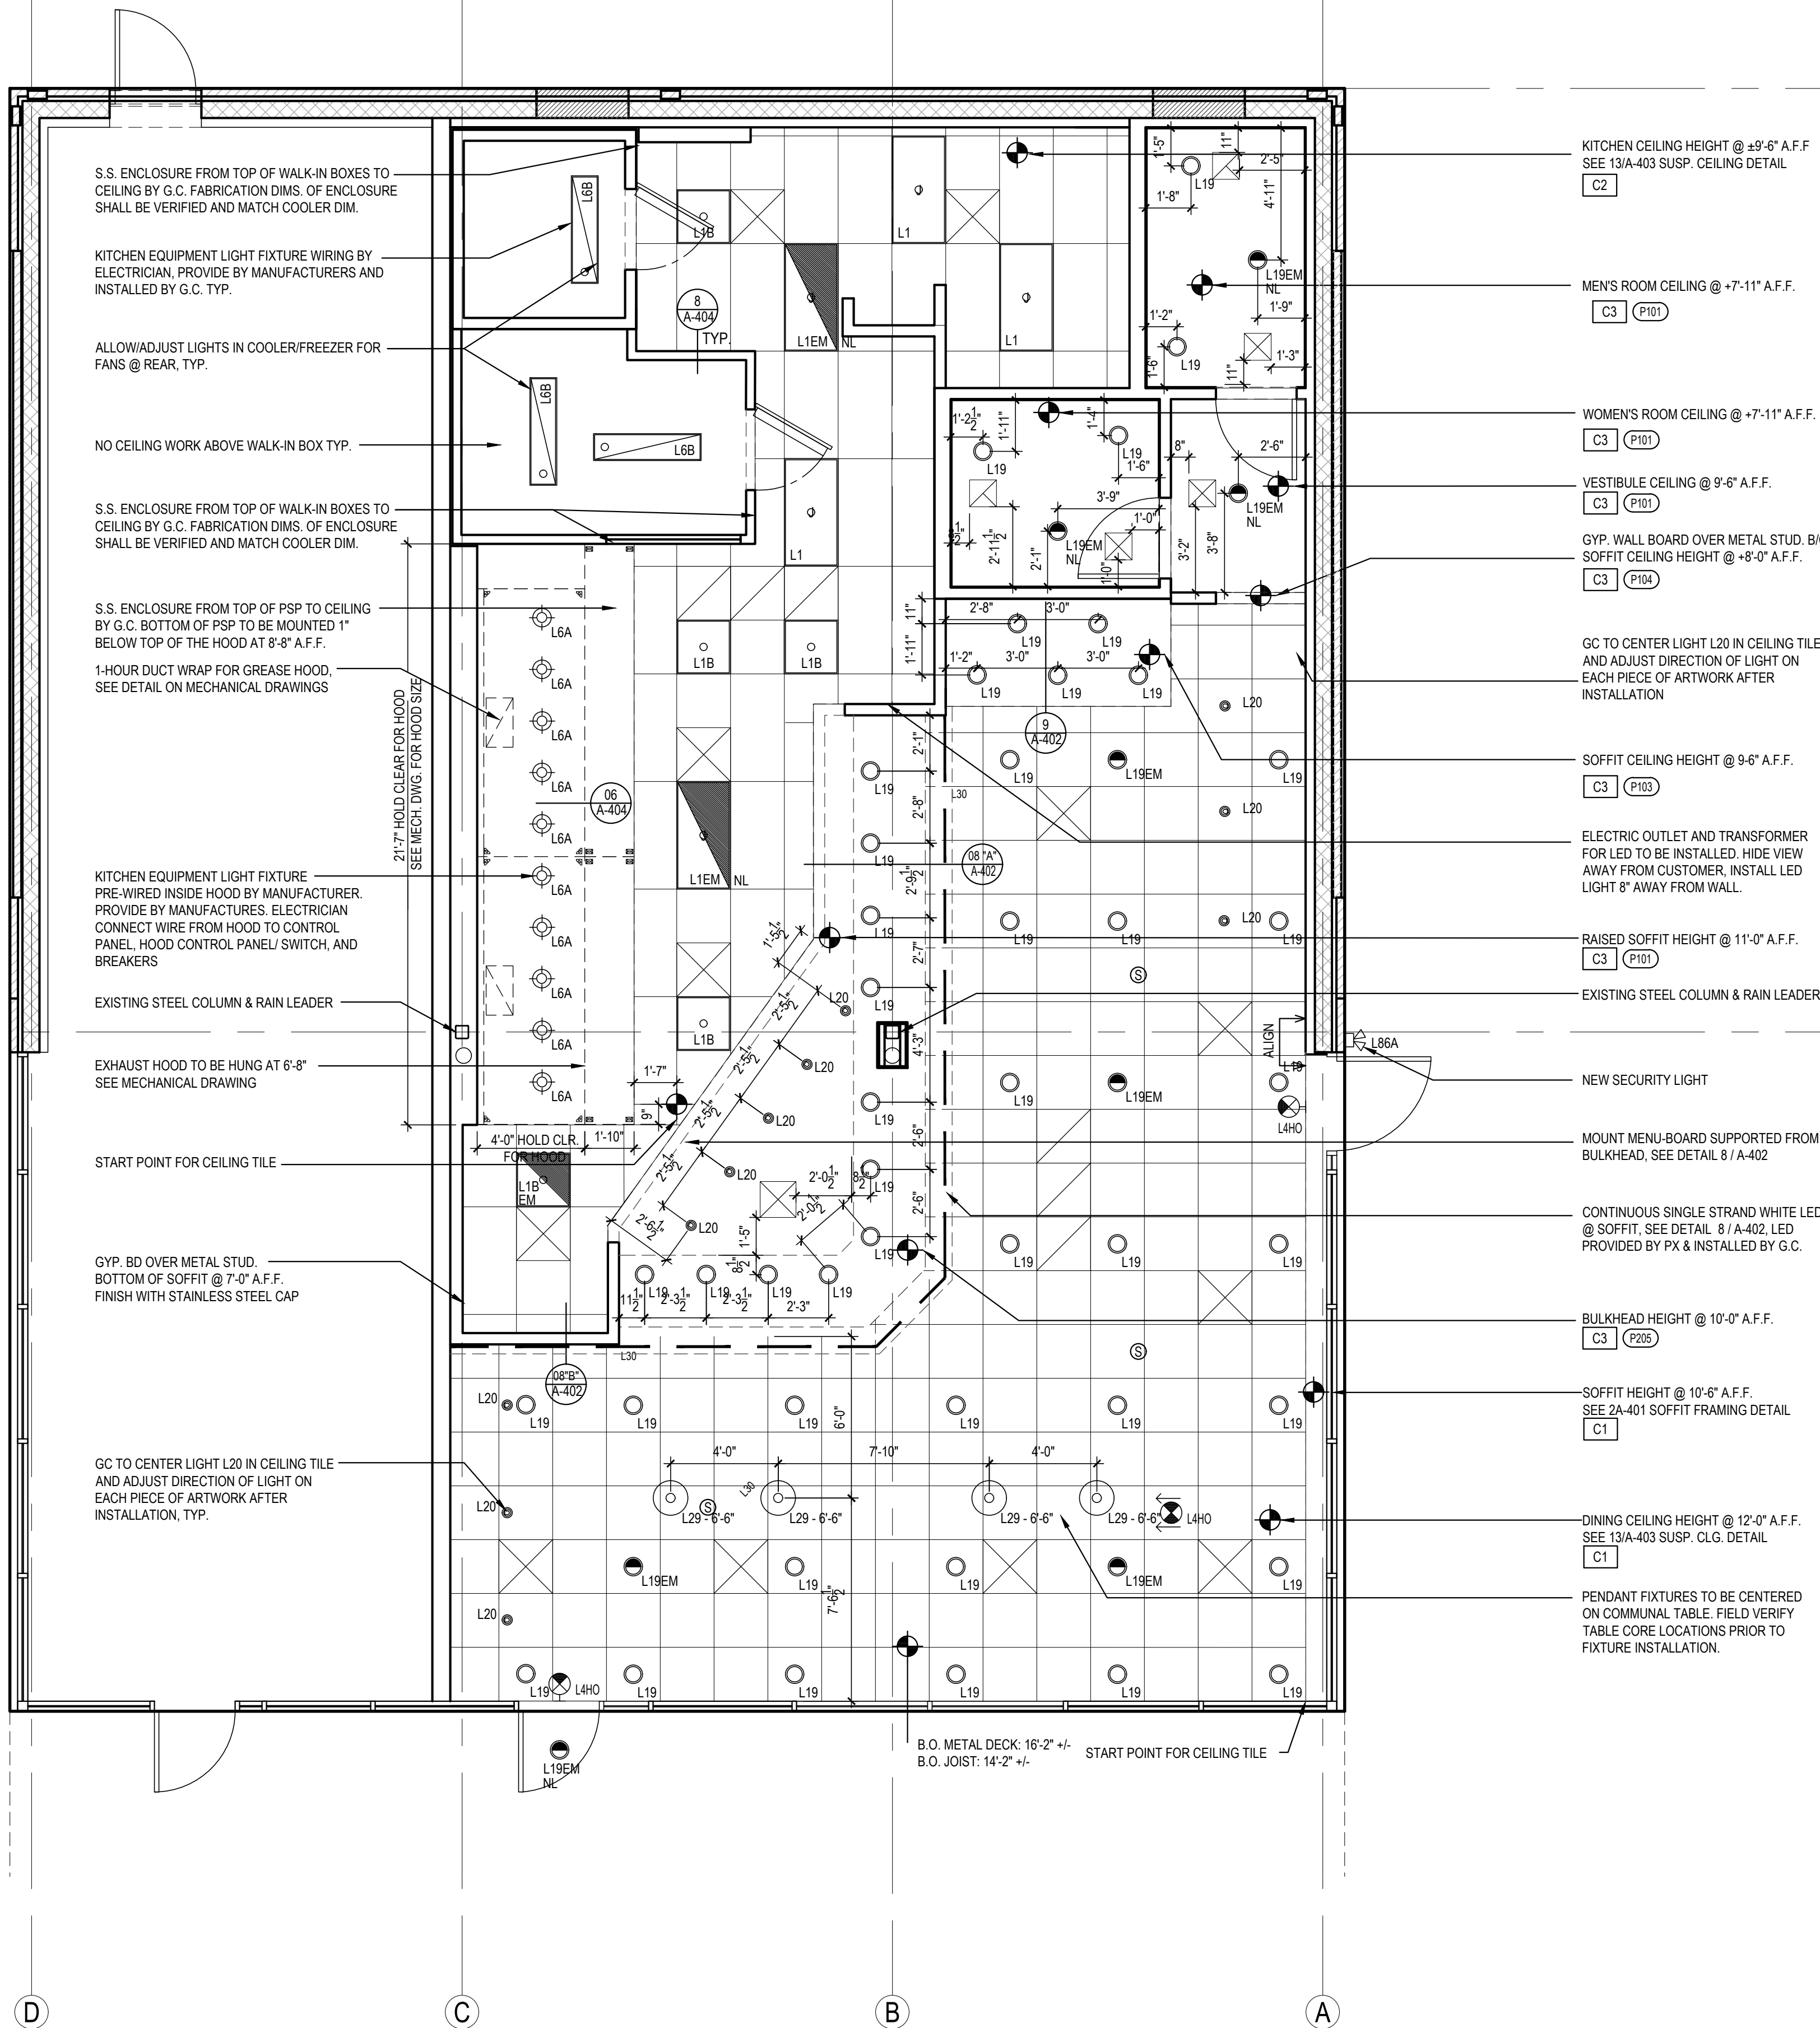
#8 GA. MIN HANGER WIRE @ OPP. CORNER FOR FIXT. WEIGHING LESS THAN 56 LBS.

LATERAL BRACING  
SEE DETAIL 13 / A-403

LIGHT FIXTURE SEE "E" DWGS FOR SPECS. PROVIDE SCREWS OR CLIPS & FASTEN FIXT. TO T-BAR

3

2



KITCHEN CEILING HEIGHT @ ±9'-6" A.F.F.  
SEE 13/A-403 SUSP. CEILING DETAIL

MEN'S ROOM CEILING @ +7'-11" A.F.F.

WOMEN'S ROOM CEILING @ +7'-11" A.F.F.

VESTIBULE CEILING @ 9'-6" A.F.F.

GYP. WALL BOARD OVER METAL STUD. B/O  
SOFFIT CEILING HEIGHT @ +8'-0" A.F.F.

GC TO CENTER LIGHT L20 IN CEILING TILE  
AND ADJUST DIRECTION OF LIGHT ON  
EACH PIECE OF ARTWORK AFTER  
INSTALLATION

SOFFIT CEILING HEIGHT @ 9'-6" A.F.F.

ELECTRIC OUTLET AND TRANSFORMER  
FOR LED TO BE INSTALLED. HIDE VIEW  
AWAY FROM CUSTOMER. INSTALL LED  
LIGHT 8" AWAY FROM WALL.

RAISED SOFFIT HEIGHT @ 11'-0" A.F.F.

EXISTING STEEL COLUMN & RAIN LEADER

NEW SECURITY LIGHT

MOUNT MENU-BOARD SUPPORTED FROM  
BULKHEAD, SEE DETAIL 8 / A-402

CONTINUOUS SINGLE STRAND WHITE LED  
@ SOFFIT. SEE DETAIL 8 / A-402. LED  
PROVIDED BY PX & INSTALLED BY G.C.

BULKHEAD HEIGHT @ 10'-0" A.F.F.

SOFFIT HEIGHT @ 10'-6" A.F.F.  
SEE 2A-401 SOFFIT FRAMING DETAIL

DINING CEILING HEIGHT @ 12'-0" A.F.F.  
SEE 13/A-403 SUSP. CLG. DETAIL

PENDANT FIXTURES TO BE CENTERED  
ON COMMUNAL TABLE. FIELD VERIFY  
TABLE CORE LOCATIONS PRIOR TO  
FIXTURE INSTALLATION.



PANDA EXPRESS, INC.

1683 Walnut Grove Ave.  
Rosemead, California  
91770

Telephone: 626.799.9898  
Facsimile: 626.372.8288

All ideas, designs, arrangement and plans indicated or represented by this drawing are the property of Panda Express Inc. and were created for use on this specific project. None of these ideas, designs, arrangements or plans may be used by or disclosed to any person, firm, or corporation without the written permission of Panda Express Inc.

#### REVISIONS:

| NO. | DESCRIPTION     | DATE       |
|-----|-----------------|------------|
| 1   | PEER REVIEW     | 01-27-2020 |
| 2   | PR RESPONSE 1   | 02-21-2020 |
| 3   | BUILDING PERMIT | 03-11-2020 |
| 4   |                 |            |
| 5   |                 |            |
| 6   |                 |            |
| 7   |                 |            |
| 8   |                 |            |
| 9   |                 |            |
| 10  |                 |            |

#### ISSUE DATE:

|                 |            |
|-----------------|------------|
| PEER REVIEW     | 01-27-2020 |
| PR RESPONSE 1   | 02-21-2020 |
| BUILDING PERMIT | 03-11-2020 |
|                 |            |
|                 |            |
|                 |            |
|                 |            |
|                 |            |
|                 |            |

DRAWN BY: CSW

PANDA PROJECT #: D7446

ARCH PROJECT #: JCDT19-0314

**NORR**  
ARCHITECTS ENGINEERS PLANNERS

PANDA EXPRESS

GREENBRIAR TOWN CENTER,  
13059 LEE JACKSON MEMORIAL HWY  
FAIRFAX, VA 22033

**A-105**

REFLECTED CEILING PLAN

REFLECTED CEILING PLAN

Scale= 1/4" = 1'-0"

1

A-105

CEILING GRID DETAIL

3

Scale= NTS

A-105

LIGHT FIXTURE DETAIL

2

Scale= NTS

A-105